


LEGEND

- EFFLUENT DRAINAGE
- DITCHES
- SECURITY FENCES
- 161 KV TRANSMISSION LINES

LEGEND

AREA	PATTERN
002	
004	
005	
006	
008	
009	
010	
011	
012	
013	
016	
017	

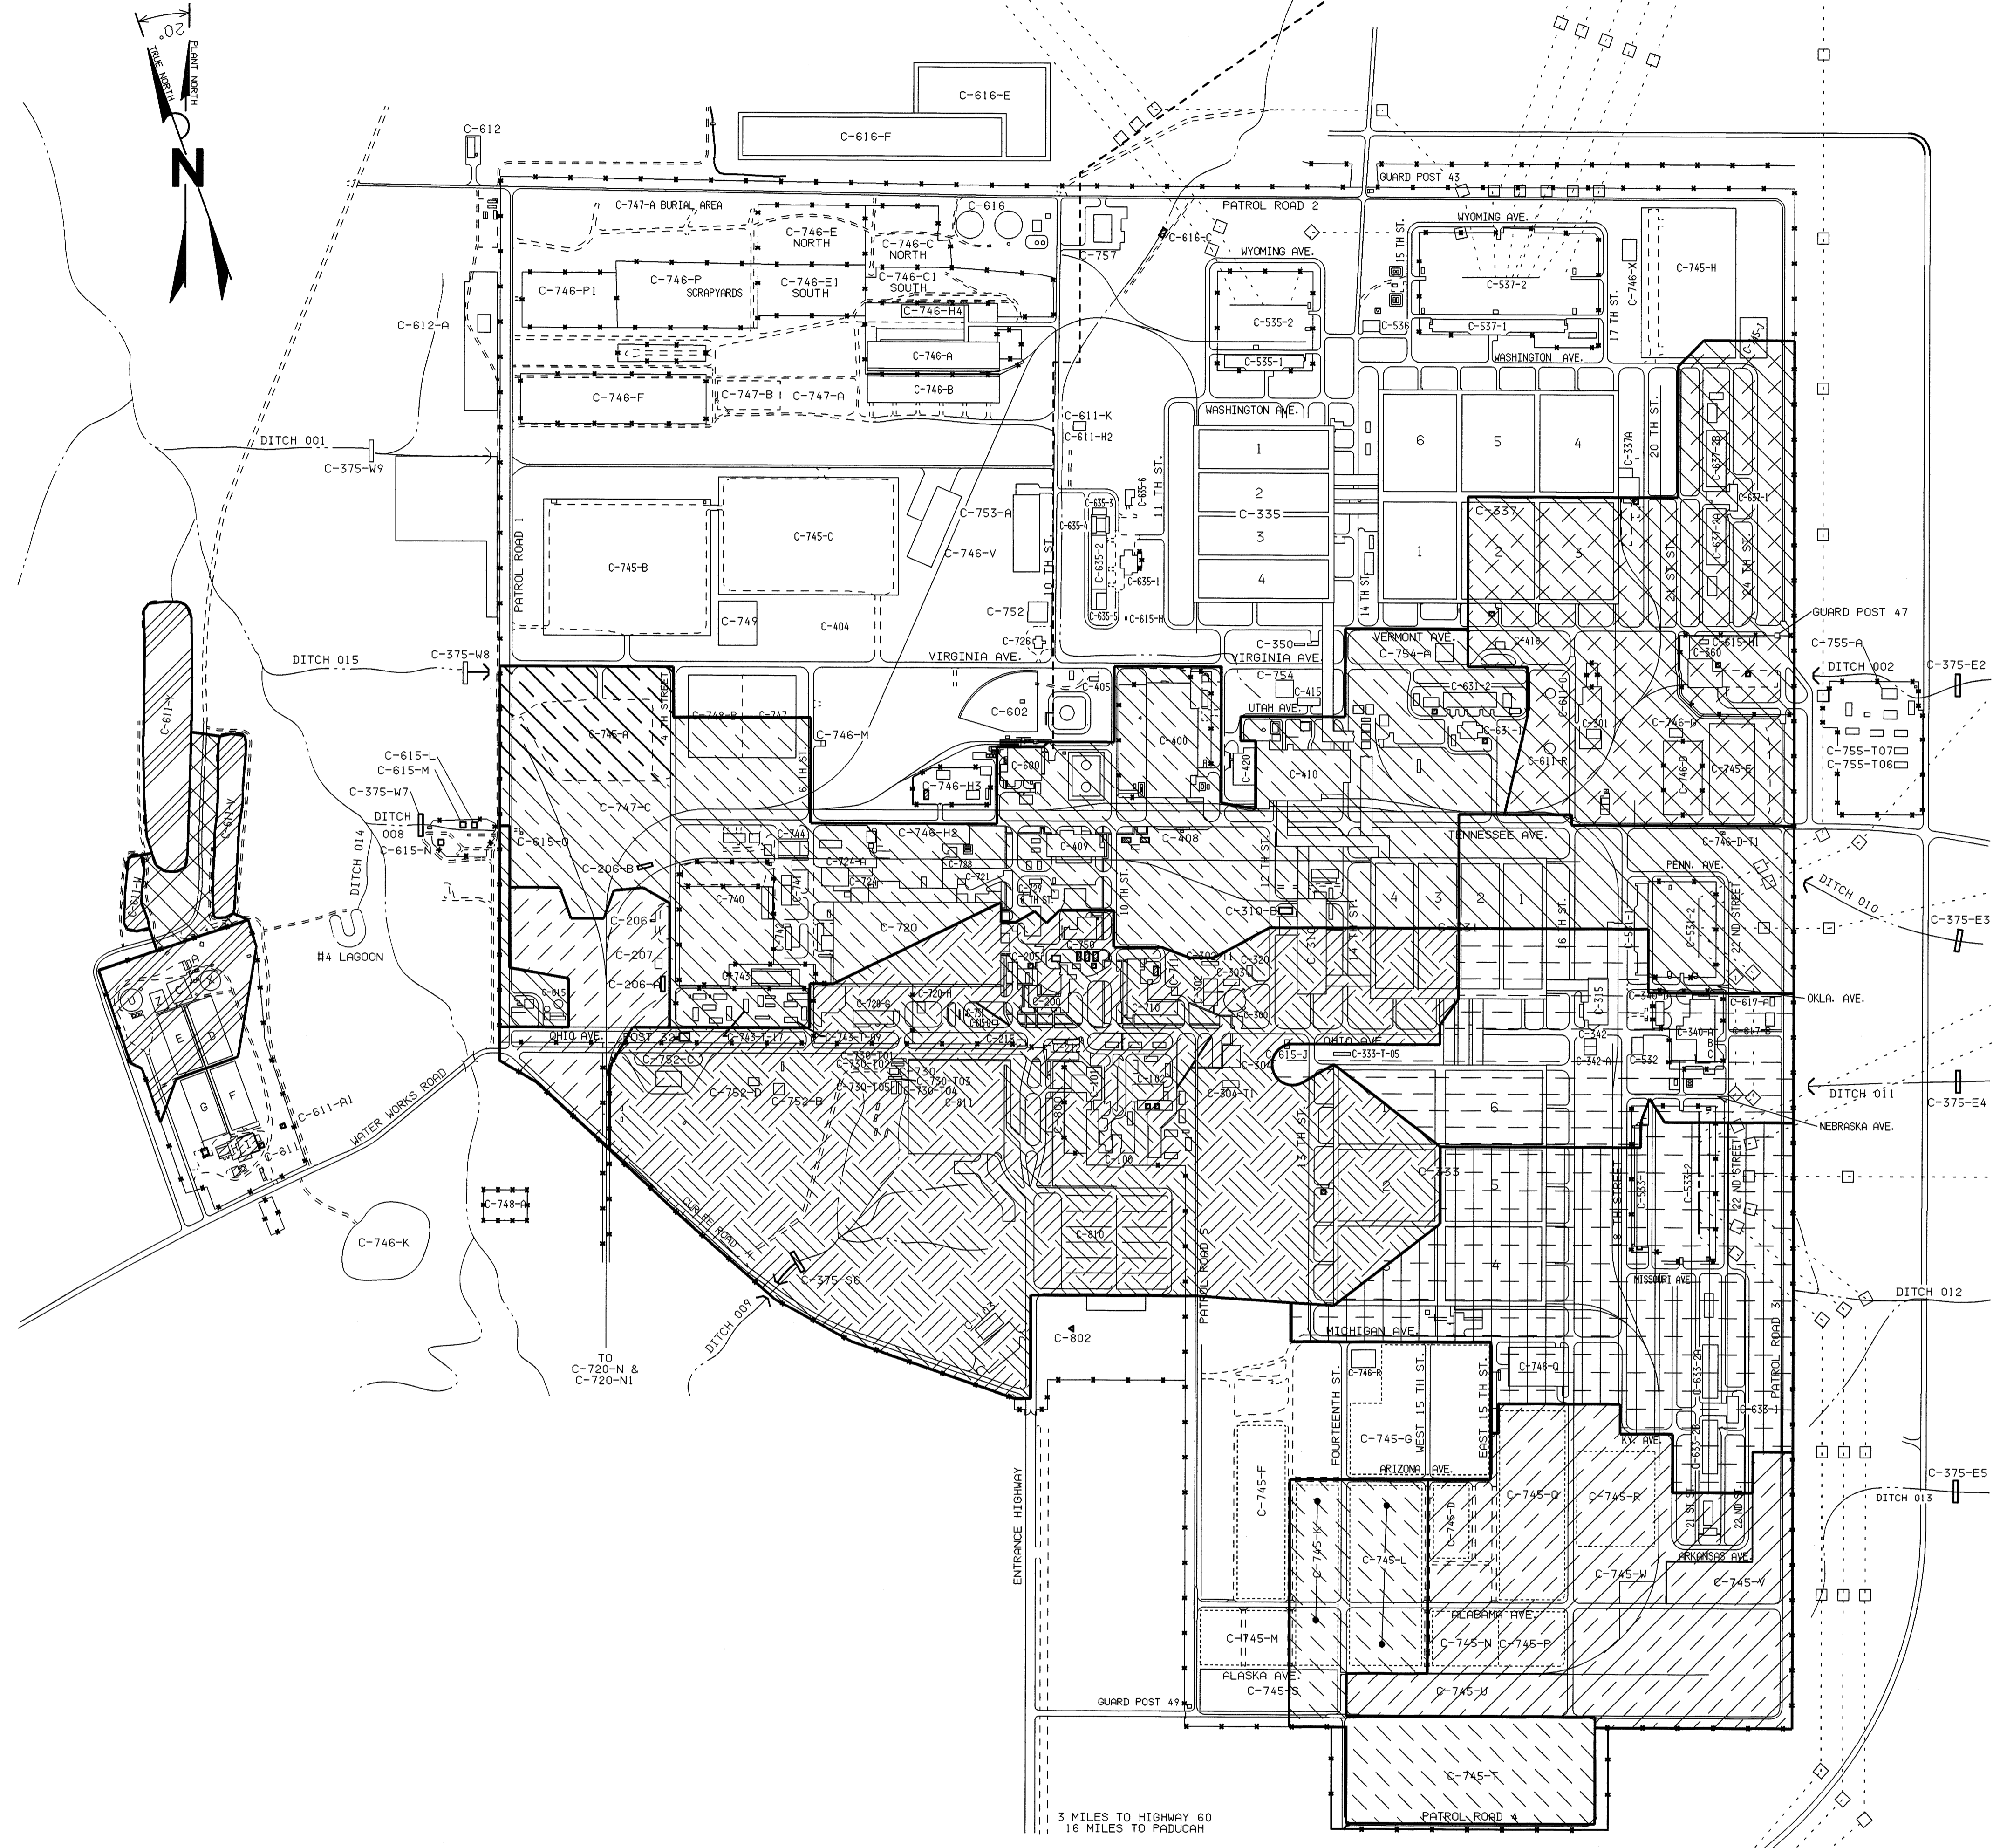


REVIEWED FOR CLASSIFICATION	REVIEWED FOR CLASSIFICATION
DBJ	KTW
06/09/2014	11/10/99
Initials	Initials
Date	Date
UNCLASSIFIED	UNCLASSIFIED

BT Images, Inc.
00097501

PRIORITY 3

THIS DRAWING PRODUCED ON CADAM
DO NOT REVISE MANUALLY

Unclassified

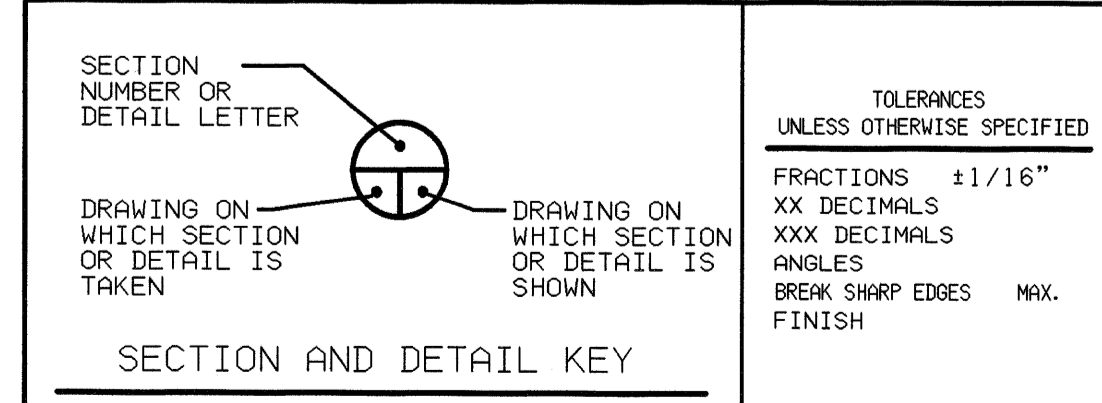

NO REPRESENTATION OR WARRANTY, EXPRESSED OR IMPLIED, IS MADE THAT THE USE OR DISCLOSURE OF ANY INFORMATION, APPARATUS, METHOD OR PROCESS DISCLOSED IN THESE DRAWINGS MAY NOT INFRINGE PRIVATE RIGHTS OF OTHERS. NO LIABILITY IS ASSUMED WITH RESPECT TO THE USE OF, OR FOR DAMAGES RESULTING FROM THE USE OF ANY INFORMATION, APPARATUS, METHOD OR PROCESS DISCLOSED IN THESE DRAWINGS. THE DRAWINGS ARE BEING MADE FOR INFORMATION TO BIDDER AND ARE NOT TO BE USED FOR OTHER PURPOSES, AND ARE TO BE RETURNED UPON REQUEST OF THE FORWARDING CONTRACTOR.

DATE	REV. NO.	ISSUE / REVISION DESCRIPTION	DATE	DRW	CHKR	RED	TR	APPD	APR
	0	AS BUILT FOR ESO Z99610 & Z90930							
	A1	APPROVED FOR RELEASE FOR ESO Z97700							

DRW	J.W. BROWN JR.	4/28/99
CHKR	K.A. HOLLAND	4/28/99
RED	J.R. BAGWELL	4/28/99
TR	N/A	
APPD	R.L. PLAUTZ	4/28/99

LOCKHEED MARTIN
LOCKHEED MARTIN UTILITY SERVICES, INC.
P.O. BOX 1410 PADUCAH, KENTUCKY 42001
ACTING UNDER CONTRACT USEC-HQ-93-C-0001 WITH THE U.S. ENRICHMENT CORPORATION

**PADUCAH GASEOUS DIFFUSION PLANT
KPDES PERMIT APPLICATION
OUTFALL DRAINAGE AREAS
SITE PLAN**

SCALE 1" = 400'
PLANT PGDP
BLDG AREA
FL SHEET OF CLASS U
ID Z97700
REV 0

C5E-19770-A01